

HARDWARE SETS																	
SET	DESCRIPTION	GENERAL NOTES															
		HINGES				LOCKSETS											
		MC 1A2714 4 1/2x4 1/2	ROTON 12HD 7500	PASSAGE RHIO	PRIVACY RHIO	NDMS - RHIO	CLASSROOM NO75FD - RHIO		RM EXIT SARGENT 28-10U65 LL	RM EXIT CLASSROOM 1550 - NUP	RM EXIT 12-4.3-888BF	FLOOR STOP	DOOR MUTE	DOOR CLOSER	PULLS	MAG HOLD OPEN	1. LOCKSETS ARE BASED ON SCHLAGE LOCKSETS. COLOR = 626 STRIKE = 13-247 STRIKE PLATE = 10-025
1	CLASSROOM	XX					XX					XX	XX				
2	STORAGE	XX										XX	XX	XX			
3	PASSAGE	XX		XX								XX	XX				
4	PRIVACY	XX			XX							XX	XX				
9	SINGLE ALUM EXT		XX							XX				XX			



ACCESSORY SCHEDULE				
MARK	DESCRIPTION	MANUFACTURER	MODEL NO.	REMARKS
	TOILET			SEE PLUMBING FIXTURE SCHEDULE
	LAVATORY			SEE PLUMBING FIXTURE SCHEDULE
	HI-LOW ELEC. WATER COOLER			SEE PLUMBING FIXTURE SCHEDULE
	TOILET TISSUE DISPENSER	BY OWNER		
	WALL MOUNTED SOAP DISPENSER	BY OWNER		
	PAPER TOWEL DISPENSER	BY OWNER		
	SANITARY NAPKIN DISPENSER	BY OWNER		
	FRAMED MIRROR	AMERICAN SPECIALTIES	0600	
	18" GRAB BAR VERTICAL	AMERICAN SPECIALTIES	3011 x 18"	TYP. AT ALL BF TOILET STALLS
	42" GRAB BAR GRAB BAR	AMERICAN SPECIALTIES	3011 x 18"	
	36" GRAB BAR GRAB BAR	AMERICAN SPECIALTIES	3011 x 18"	

DOOR SCHEDULE												
NO.	ROOM NAME	DOOR		FRAME				ASSY	JAMB	GLAZING	REMARKS	
		SIZE	TYPE	MAT'L	FINISH	TYPE	MAT'L					FINISH
EX01	COMMON AREA	3'-0"x7'-0"x1 3/4"									EXISTING DOOR AND FRAME	
101A	ENTRY	3'-0"x7'-0"x1 3/4"	N	HM	PAINT	II	PAINT	PAINT		INSUL		
101B	ENTRY	3'-0"x7'-0"x1 3/4"	N	HM	PAINT	I	PAINT	PAINT		1/4" LAM		
103A	OFFICE	3'-0"x7'-0"x1 3/4"	N	HM	PAINT	I	PAINT	PAINT	1	1/4" LAM		
104A	REGROUP	3'-0"x7'-0"x1 3/4"	N	HM	PAINT	I	PAINT	PAINT	1	1/4" LAM		
105A	CLASSROOM	3'-0"x7'-0"x1 3/4"	N	HM	PAINT	I	PAINT	PAINT	3	1/4" LAM		
EX02	CLASSROOM	3'-0"x7'-0"x1 3/4"							9		REPLACE EXIT HANDLE TO RIM PANC	
106A	CLASSROOM	3'-0"x7'-0"x1 3/4"	N	HM	PAINT	I	PAINT	PAINT	3	1/4" LAM		
106B		3'-2"x7'-0"x1 3/4"	F	FG	ALUM	ANOD	EX	EXT		INSUL	FIELD VERIFY FRAME OPENING	
107A	JC	3'-0"x7'-0"x1 3/4"	N	HM	PAINT	i	HM	PAINT	1			
108A	SERVING	3'-0"x7'-0"x1 3/4"	N	HM	PAINT	I	HM	PAINT	1	1/4" LAM		
109A	MENS TOILET	3'-0"x7'-0"x1 3/4"	F	HM	PAINT	i	1	PAINT	4			
110A	WOMENS TOILET	3'-0"x7'-0"x1 3/4"	F	HM	PAINT	i	1	PAINT	4			

DOOR TYPES

Diagram illustrating three door types and their specifications:



- TYPE FG:** HW DOOR SEE SCHEDULE FOR FIRE RATING AND INSULATION. ALUM DOOR SEE SCHEDULE WITH INSULATED OR LAMINATED GLAZING.
- TYPE F:** (No specific text label provided in the diagram).
- TYPE N:** 1/4" GLAZING SEE DOOR SCHEDULE. SOLID CORE SEE DOOR SCHEDULE FOR FIRE RATING. Dimensions: 8" (width), 8" (height), 7" (height), 7" (height).

FRAME TYPE

The diagram illustrates three types of door frame configurations, labeled TYPE I, TYPE II, and TYPE III. Each type shows a door with a 2' width and a 2' height, with labels for 'HM FRAME' and 'SEE DOOR SCHEDULE'.

- TYPE I:** A single door with a 2' width and a 2' height. The label 'HM FRAME' points to the top and bottom horizontal members. The label 'SEE DOOR SCHEDULE' points to the door panel.
- TYPE II:** A single door with a 2' width and a 2' height. The label 'HM FRAME' points to the top and bottom horizontal members. The label 'SEE DOOR SCHEDULE' points to the door panel.
- TYPE III:** A door with a 2' width and a 2' height, flanked by two sidelights, each 2' wide. The label 'HM FRAME' points to the top and bottom horizontal members. The label 'SEE DOOR SCHEDULE' points to the door panel. The label 'SIDELIGHT' points to the glass panels on either side of the door.

 DOOR TYPE LEGEND
 SCALE : NTS

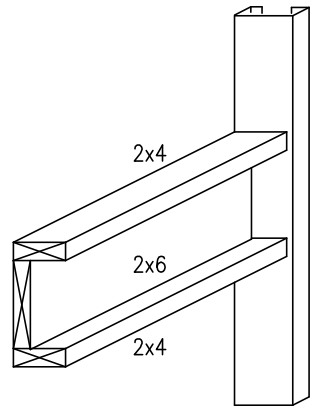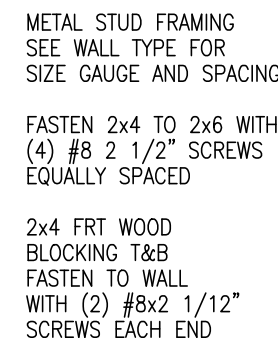


A-5
A101

ENLARGED TOILET ROOM

SCALE : 1/4" = 1'-0"


 GRAB BAR BACKING
 SCALE : 1/4" = 1'-0"

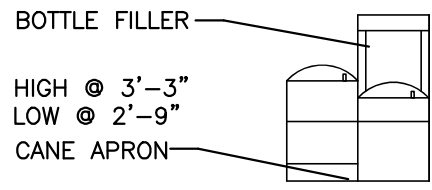

B-5 TOILET ROOM
A101 SCALE : 1/4" = 1'-0"

B-6 TOILET ROOM
A101 SCALE : 1/4" = 1'-0"

B-7 FOUNTAIN
A101 SCALE : 1/4" = 1'-0"

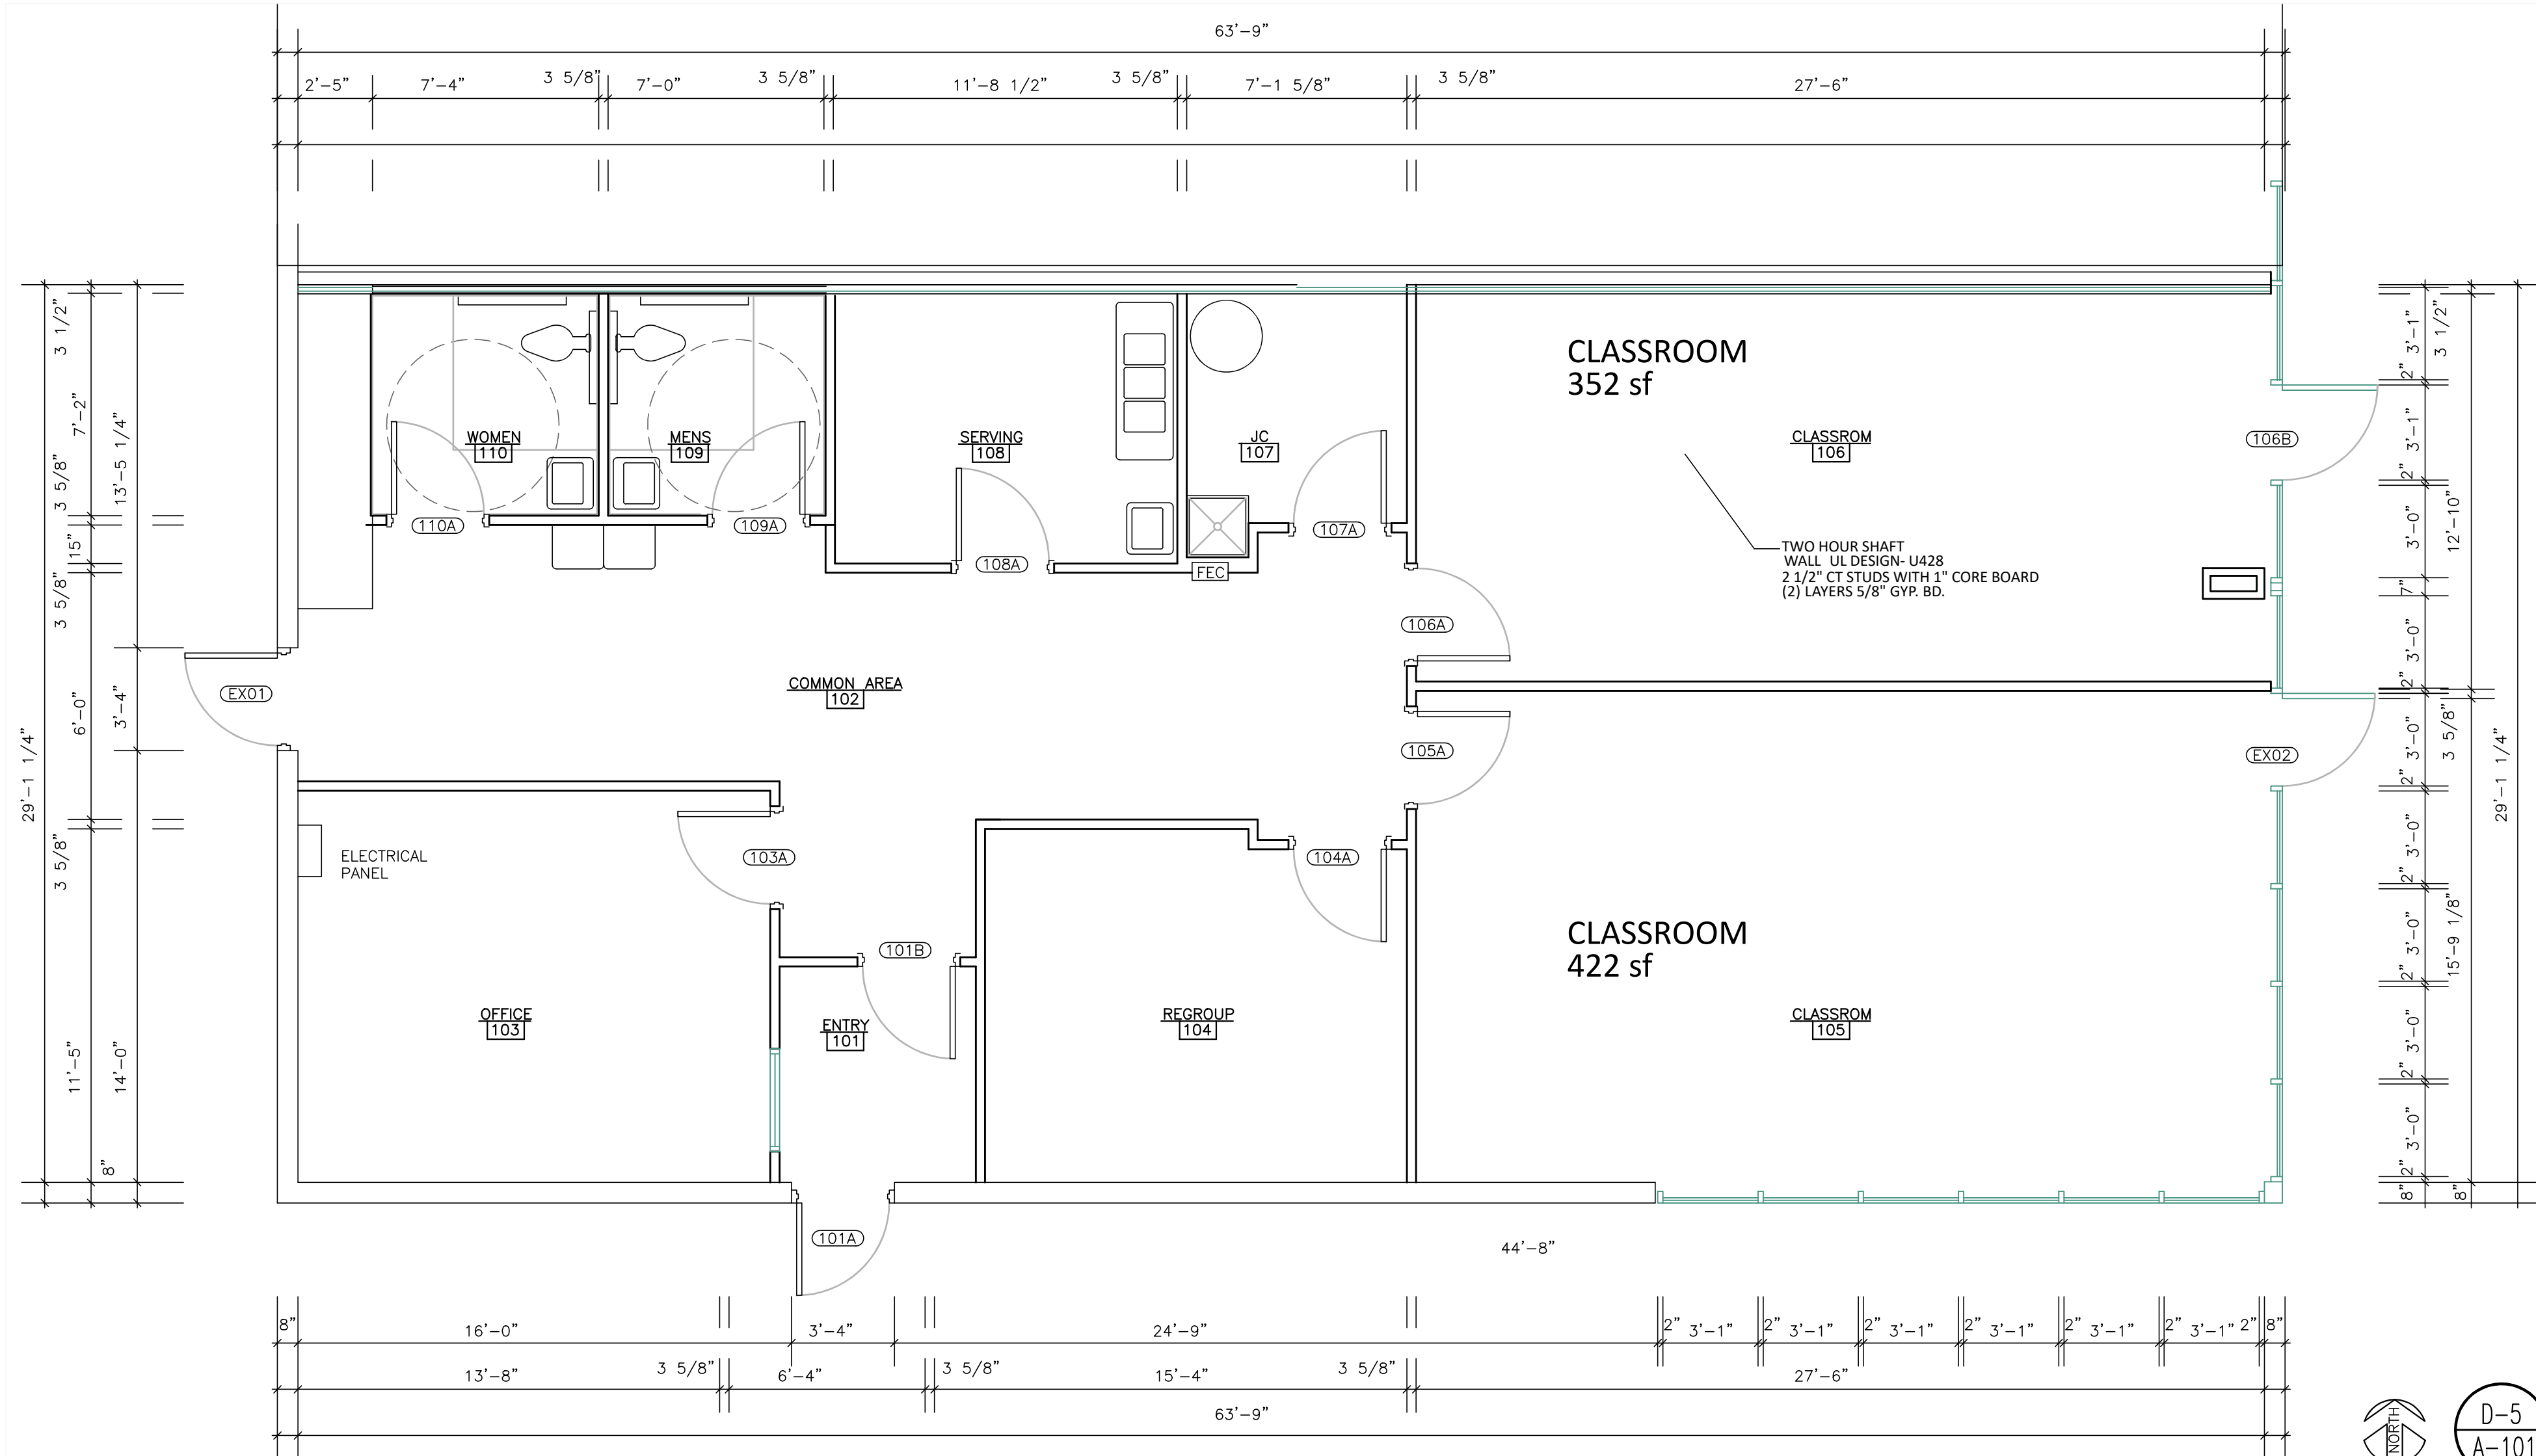

FLOOR PLAN
 SCALE : 1/4"=1'-0"

OWNER SIGNOFF

LIGHTHOUSE NORTH
151 S MAIN

CEDAR SPRINGS MICHIGAN 49319

RMD
ARCHITECT

616 677 5997 OFFICE
616 813 2452 MOBILE
RMD@RMDArchitects.net
1744 MARNE ESTATES DR.
TALLMADGE TOWNSHIP, MI 49435

USED FOR:
VIEW

DATE: 01/19

SEA

PROJECT NUMBER

PROJECT #

SHEET NUMBER

A-101

SHEET NAME

FLOOR PLAN